



DRAWING LIST

SHEET NO.	DWG. NO.	SHEET TITLE
1.	CV	COVER SHEET
2.	GN	GENERAL NOTES, LEGEND, ABBREVIATIONS, AND UTILITY LIST
3.	IN	SANITARY SEWER INDEX MAP AND DRAWING LIST
4.	PP-1	SANITARY SEWER PLAN AND PROFILE - CREEK ROAD
5.	PP-2	LOW PRESSURE SANITARY SEWER PLAN AND PROFILE - CREEK ROAD
6.	PP-3	SANITARY SEWER PLAN AND PROFILE - CREEK ROAD
7.	PP-4	SANITARY SEWER PLAN AND PROFILE - PETERS MOUNTAIN ROAD
8.	PP-5	SANITARY SEWER PLAN AND PROFILE - PETERS MOUNTAIN ROAD
9.	PP-6	SANITARY SEWER PLAN AND PROFILE - PETERS MOUNTAIN ROAD
10.	PP-7	SANITARY SEWER PLAN AND PROFILE - HILL DRIVE
11.	PP-8	SANITARY SEWER PLAN AND PROFILE - PETERS MOUNTAIN ROAD
12.	PP-9	SANITARY SEWER PLAN AND PROFILE - PETERS MOUNTAIN ROAD
13.	PP-10	SANITARY SEWER PLAN AND PROFILE - PETERS MOUNTAIN ROAD
14.	PP-11	SANITARY SEWER PLAN AND PROFILE - PETERS MOUNTAIN ROAD
15.	PP-12	SANITARY SEWER PLAN AND PROFILE - MILLION DOLLAR ROAD
16.	PP-13	SANITARY SEWER PLAN AND PROFILE - CLOVER LANE AND WILLIAMS STREET
17.	PP-14	LOW PRESSURE SANITARY SEWER PLAN AND PROFILE - ROADCAP LANE
18.	PP-15	LOW PRESSURE SANITARY SEWER PLAN AND PROFILE - MATAMORAS ROAD
19.	PP-16	SANITARY SEWER PLAN AND PROFILE - ELM AVENUE AND SYCAMORE AVENUE
20.	PP-17	SANITARY SEWER PLAN AND PROFILE - DAK AVENUE
21.	PP-18	LOW PRESSURE SANITARY SEWER PLAN AND PROFILE - SOUTH RIVER ROAD (S.R. 147)
22.	PP-19	SANITARY SEWER PLAN AND PROFILE - FELLOWSHIP DRIVE
23.	PP-20	LOW PRESSURE SANITARY SEWER PLAN AND PROFILE - FELLOWSHIP DRIVE
24.	PP-21	LOW PRESSURE SANITARY SEWER PLAN AND PROFILE - FARMER DRIVE
25.	PP-22	LOW PRESSURE SANITARY SEWER PLAN AND PROFILE - FARMER DRIVE
26.	PP-23	LOW PRESSURE SANITARY SEWER PLAN AND PROFILE - GALLI ROAD
27.	PP-24	LOW PRESSURE SANITARY SEWER PLAN AND PROFILE - LAUREN LANE
28.	PP-25	LOW PRESSURE SANITARY SEWER PLAN AND PROFILE - POWELLS VALLEY ROAD
29.	PP-26	LOW PRESSURE SANITARY SEWER PLAN AND PROFILE - POWELLS VALLEY ROAD
30.	PP-27	LOW PRESSURE SANITARY SEWER PLAN AND PROFILE - POWELLS VALLEY ROAD
31.	PP-28	LOW PRESSURE SANITARY SEWER PLAN AND PROFILE - MAPLE AVENUE
32.	PP-29	SANITARY SEWER PLAN AND PROFILE - PETERS MOUNTAIN ROAD
33.	FMCR-1	FORCE MAIN PLAN AND PROFILE - CREEK ROAD PUMP STATION
34.	FMCR-2	FORCE MAIN PLAN AND PROFILE - CREEK ROAD PUMP STATION
35.	FML-1	FORCE MAIN AND GRAVITY SEWER PLAN AND PROFILE - LENKER PUMP STATION
36.	FML-2	FORCE MAIN PLAN AND PROFILE - LENKER PUMP STATION
37.	FMRL-1	FORCE MAIN PLAN AND PROFILE - ROADCAP LANE PUMP STATION
38.	FMRL-2	FORCE MAIN PLAN AND PROFILE - ROADCAP LANE PUMP STATION
39.	FMRL-3	FORCE MAIN PLAN AND PROFILE - ROADCAP LANE PUMP STATION
40.	W-1	CREEK ROAD WATER MAIN EXTENSION
41.	CR-1	CREEK ROAD PUMP STATION - EXISTING CONDITIONS AND DEMOLITION SITE PLAN
42.	CR-2	CREEK ROAD PUMP STATION - EROSION AND SEDIMENTATION CONTROL SITE PLAN
43.	CR-3	CREEK ROAD PUMP STATION - SITE PREPARATION PLAN
44.	CR-4	CREEK ROAD PUMP STATION - SITE GRADING AND SURFACING PLAN
45.	CR-5	CREEK ROAD PUMP STATION - PROPOSED SITE PLAN
46.	CR-6	CREEK ROAD PUMP STATION - PLAN AND SECTIONAL ELEVATION
47.	L-1	LENKER PUMP STATION - EXISTING CONDITIONS AND DEMOLITION SITE PLAN
48.	L-2	LENKER PUMP STATION - EROSION AND SEDIMENTATION CONTROL SITE PLAN
49.	L-3	LENKER PUMP STATION - SITE PREPARATION PLAN
50.	L-4	LENKER PUMP STATION - SITE GRADING AND SURFACING PLAN
51.	L-5	LENKER PUMP STATION - PROPOSED SITE PLAN
52.	L-6	LENKER PUMP STATION - PLAN
53.	L-7	LENKER PUMP STATION - SECTIONS
54.	RL-1	ROADCAP LANE PUMP STATION - EXISTING CONDITIONS AND DEMOLITION SITE PLAN
55.	RL-2	ROADCAP LANE PUMP STATION - EROSION AND SEDIMENTATION CONTROL SITE PLAN
56.	RL-3	ROADCAP LANE PUMP STATION - SITE PREPARATION PLAN
57.	RL-4	ROADCAP LANE PUMP STATION - SITE GRADING AND SURFACING PLAN
58.	RL-5	ROADCAP LANE PUMP STATION - PROPOSED SITE PLAN
59.	RL-6	ROADCAP LANE PUMP STATION - PLAN
60.	RL-7	ROADCAP LANE PUMP STATION - SECTIONS
61.	LS-1	LANDSCAPING PLAN
62.	DT-1	MISCELLANEOUS CONSTRUCTION DETAILS
63.	DT-2	MISCELLANEOUS CONSTRUCTION DETAILS
64.	DT-3	MISCELLANEOUS CONSTRUCTION DETAILS
65.	DT-4	MISCELLANEOUS CONSTRUCTION DETAILS
66.	DT-5	MISCELLANEOUS CONSTRUCTION DETAILS
67.	DT-6	MISCELLANEOUS CONSTRUCTION DETAILS
68.	DT-7	MISCELLANEOUS CONSTRUCTION DETAILS
69.	DT-8	MISCELLANEOUS CONSTRUCTION DETAILS
70.	DT-9	RETAINING WALL DETAILS
71.	DT-10	EROSION AND SEDIMENTATION POLLUTION CONTROL DETAILS
72.	DT-11	EROSION AND SEDIMENTATION POLLUTION CONTROL DETAILS
73.	DT-12	EROSION AND SEDIMENTATION POLLUTION CONTROL NOTES
74.	S-1	LENKER ESTATES AND ROADCAP LANE PUMP STATIONS STRUCTURAL GENERAL NOTES AND CODE INFORMATION
75.	S-2	LENKER ESTATES AND ROADCAP LANE PUMP STATIONS STRUCTURAL DETAILS
76.	S-3	LENKER ESTATES AND ROADCAP LANE PUMP STATIONS STRUCTURAL PLANS
77.	S-4	LENKER ESTATES AND ROADCAP LANE PUMP STATIONS STRUCTURAL ELEVATIONS
78.	S-5	LENKER ESTATES AND ROADCAP LANE PUMP STATIONS STRUCTURAL SECTIONS
79.	S-6	CREEK ROAD PUMP STATION STRUCTURAL DETAILS
80.	A-01	LENKER ESTATES & ROADCAP LANE PUMP STATIONS ARCHITECTURAL PROJECT GENERAL NOTES, SYMBOLS, & ABBREVS
81.	A-02	LENKER ESTATES & ROADCAP LANE PUMP STATIONS ARCHITECTURAL GENERAL - ADA DETAILS
82.	A-03	LENKER ESTATES & ROADCAP LANE PUMP STATIONS LIFE SAFETY PLAN AND CODE ANALYSIS
83.	A-04	LENKER ESTATES & ROADCAP LANE PUMP STATIONS ASSEMBLIES & MISC. DETAILS
84.	A-05	LENKER ESTATES PUMP STATION ARCH. FLOOR PLAN, ROOF PLAN, & RCP
85.	A-06	LENKER ESTATES PUMP STATION EXTERIOR ELEVATIONS & BUILDING SECTIONS
86.	A-07	ROADCAP LANE PUMP STATION ARCH. FLOOR PLAN, ROOF PLAN, & RCP
87.	A-08	ROADCAP LANE PUMP STATION EXTERIOR ELEVATIONS & BUILDING SECTIONS
88.	A-09	LENKER ESTATES & ROADCAP LANE PUMP STATIONS WALL SECTIONS & DETAILS
89.	A-10	LENKER ESTATES & ROADCAP LANE PUMP STATIONS ROOM & DOOR SCHED, DOOR DETAILS, & MISC. DETAILS
90.	H-01	LENKER ESTATES PUMP STATION HVAC FLOOR PLAN, NOTES, SCHEDULES & DETAILS
91.	H-02	ROADCAP LANE PUMP STATION HVAC FLOOR PLAN, NOTES, SCHEDULES & DETAILS
92.	P-01	LENKER ESTATES PUMP STATION PLUMBING FLOOR PLAN, NOTES, SCHEDULES & DETAILS
93.	P-02	ROADCAP LANE PUMP STATION PLUMBING FLOOR PLAN, NOTES, SCHEDULES & DETAILS
94.	E-1	NOTES, ABBREVIATIONS AND SYMBOLS
95.	E-2	CREEK ROAD PUMP STATION SITE PLANS, DETAILS, DUCTBANK SCHEDULE AND SECTIONS
96.	E-3	CREEK ROAD PUMP STATION POWER ONE-LINE DIAGRAM AND SCHEDULE
97.	E-4	CREEK ROAD PUMP STATION CONTROL ONE-LINE DIAGRAMS
98.	E-5	CREEK ROAD PUMP STATION KIOSK PANEL MOUNTING STAND AND DETAILS
99.	E-6	LENKER PUMP STATION SITE PLAN, DUCTBANK SCHEDULE AND SECTIONS
100.	E-7	LENKER PUMP STATION PROPOSED ELECTRICAL PLAN AND DETAIL
101.	E-8	LENKER PUMP STATION POWER ONE-LINE DIAGRAM AND SCHEDULE
102.	E-9	LENKER PUMP STATION CONTROL ONE-LINE DIAGRAMS
103.	E-10	ROADCAP LANE PUMP STATION SITE PLANS, DUCTBANK SCHEDULE AND SECTIONS
104.	E-11	ROADCAP LANE PUMP STATION PROPOSED ELECTRICAL PLAN AND DETAIL
105.	E-12	ROADCAP LANE PUMP STATION POWER ONE-LINE DIAGRAM AND SCHEDULE
106.	E-13	ROADCAP LANE PUMP STATION CONTROL ONE-LINE DIAGRAMS
107.	E-14	STANDARD CONTROL PANELS/DIAGRAMS
108.	E-15	STANDARD DETAILS
109.	E-16	STANDARD DETAILS

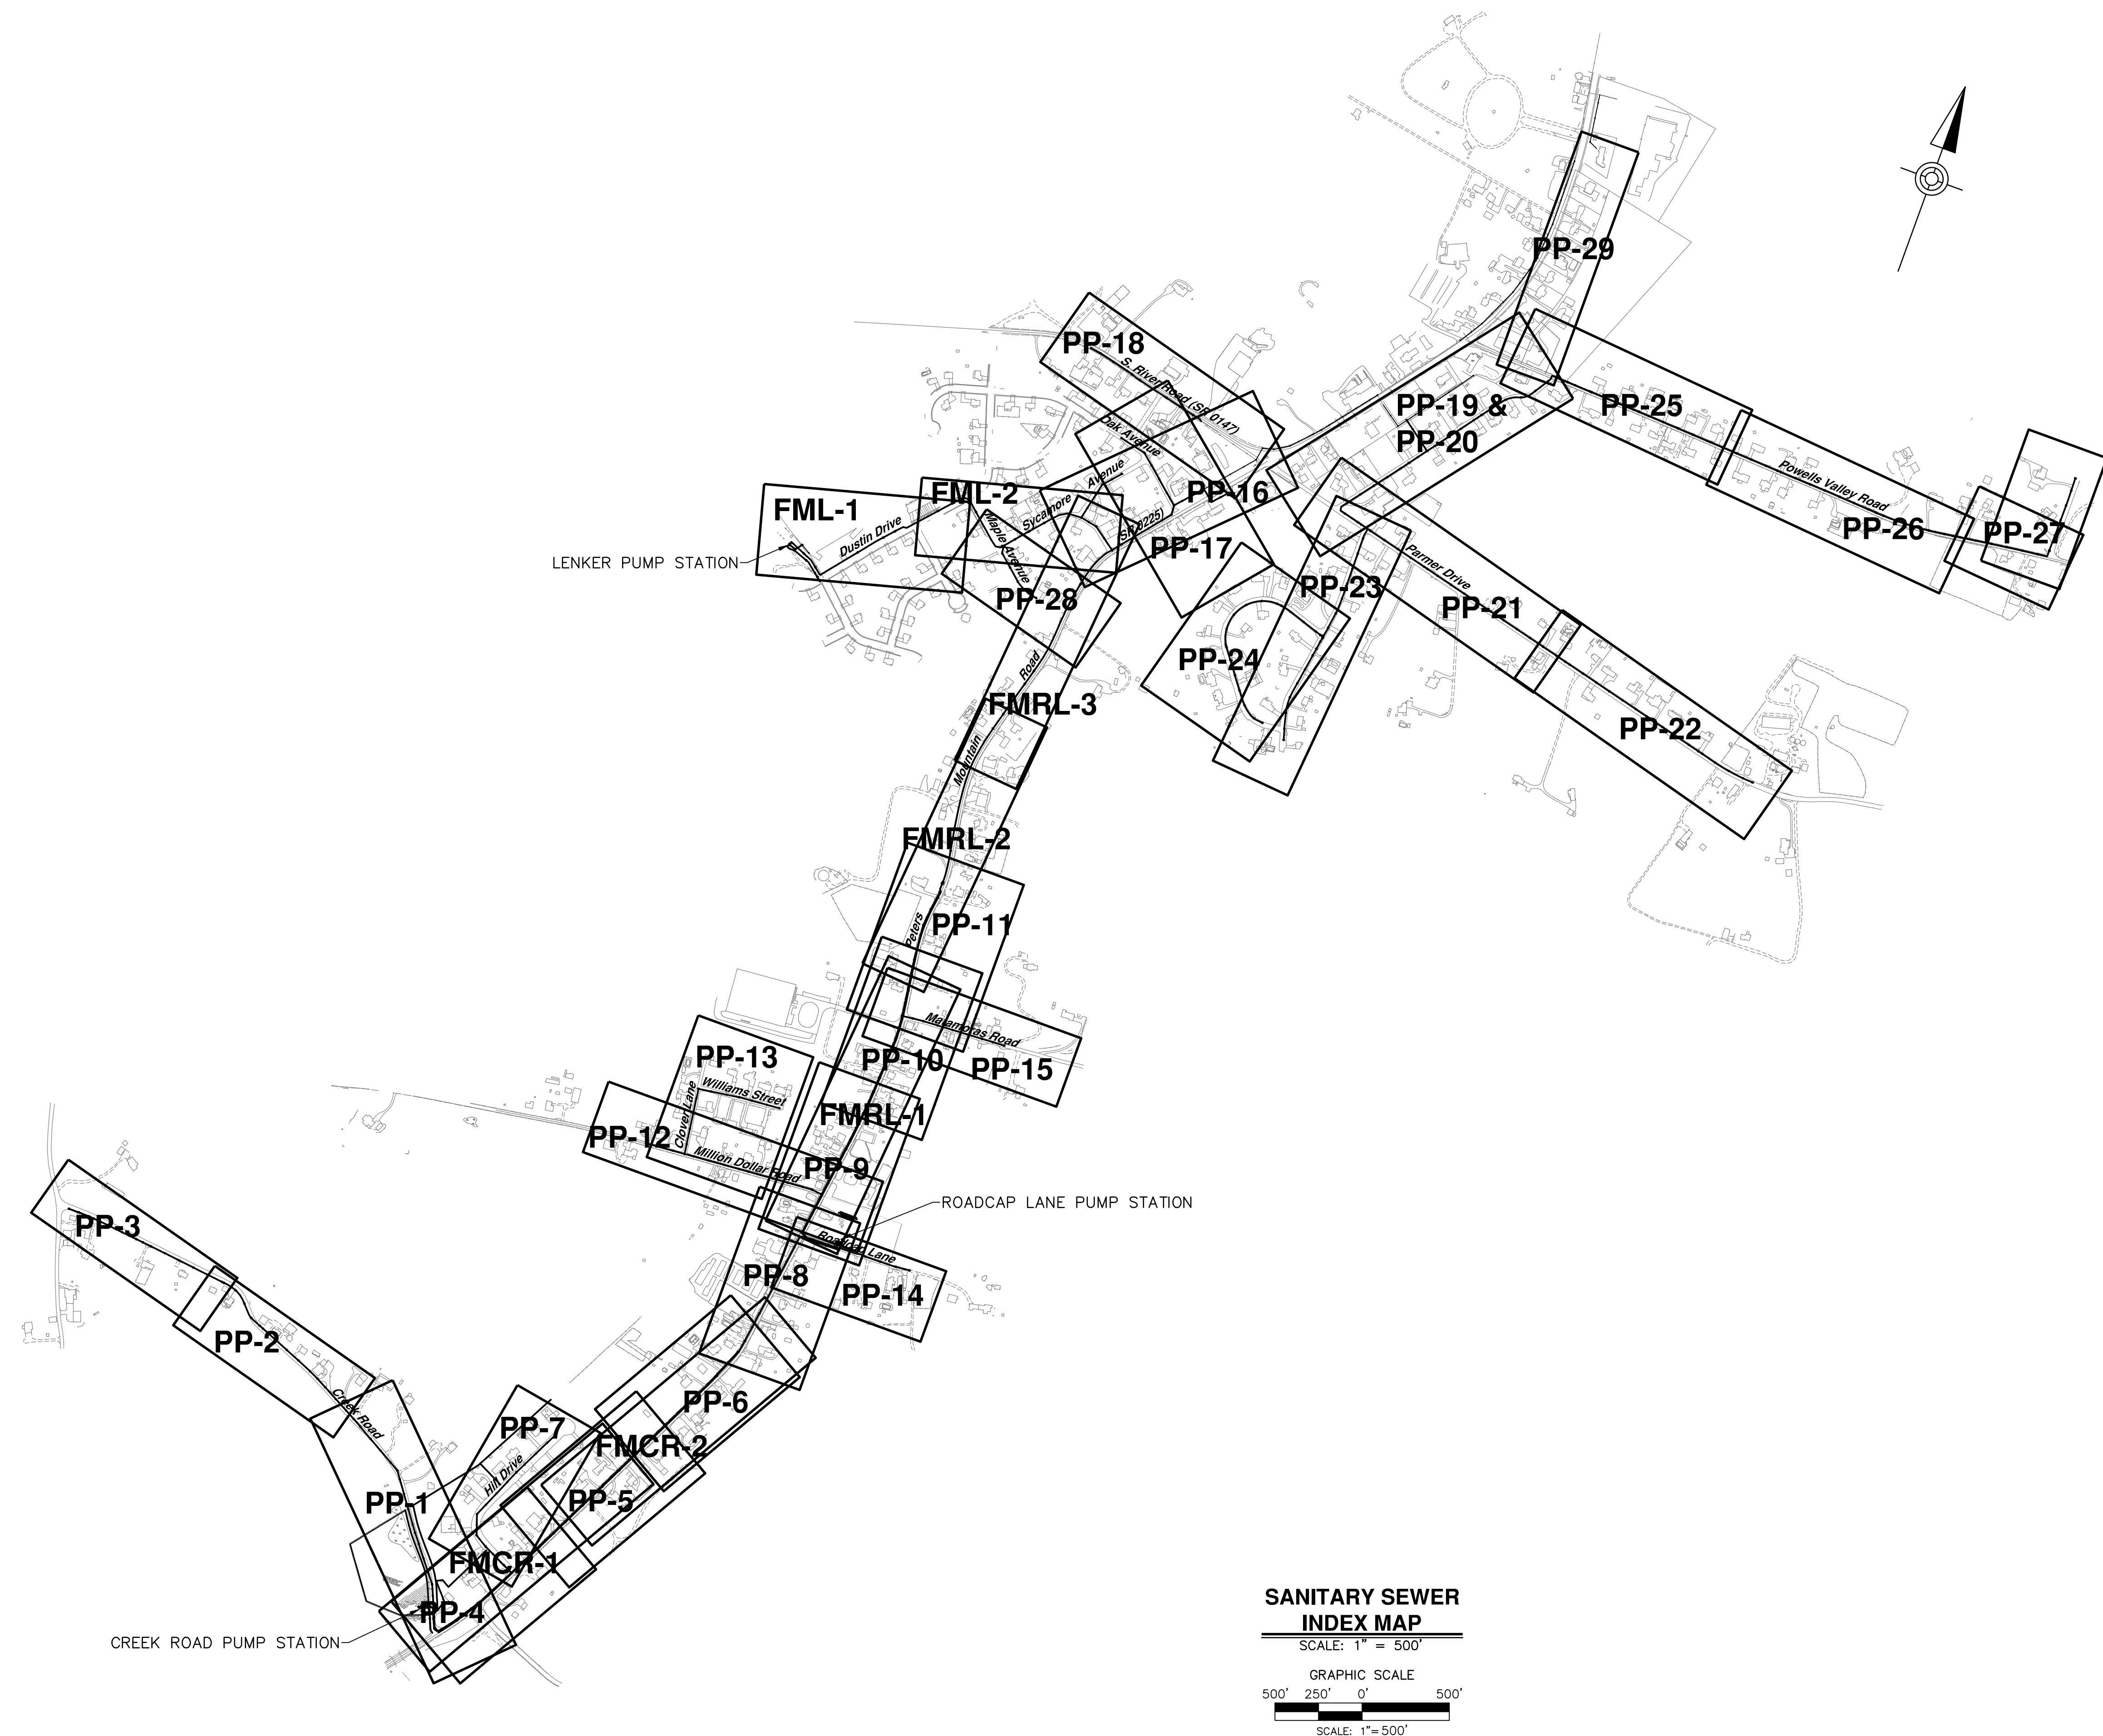

NO.	REVISION	DATE	BY

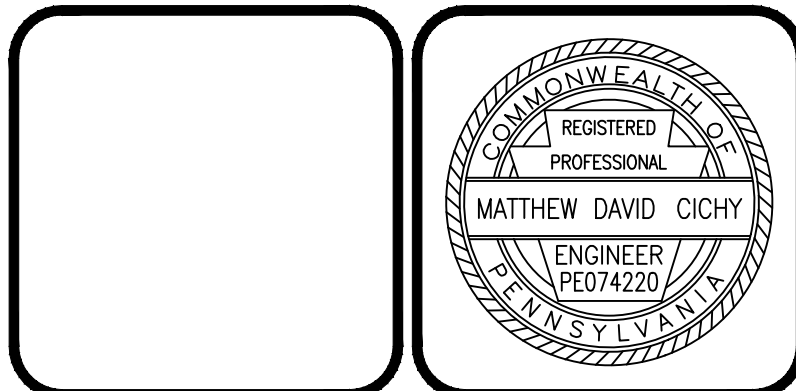

HRG
Herbert, Rowland & Grubic, Inc.
Engineering & Related Services
AN EMPLOYEE-OWNED COMPANY

369 East Park Drive
Harrisburg, PA 17111
(717) 564-1121
Fax (717) 564-1158
hr@hrg-inc.com
www.hrg-inc.com

HALIFAX AREA
WATER AND SEWER AUTHORITY
203 ARMSTRONG STREET
HALIFAX, PA 17032
(717) 896-8083

SANITARY SEWER INDEX MAP
AND DRAWING LIST
FOR
HALIFAX TWP. SANITARY SEWER EXTENSION PROJECT
HALIFAX TOWNSHIP DAUPHIN COUNTY PENNSYLVANIA

PROJ. MGR. - JUM
DESIGN- MDC
CADD- BAB
CHECKED-MDC
SCALE- AS NOTED
DATE- AUG. 2022

DRAWING NO.
IN
SHEET NO.
3 OF 109
PROJECT 001650.0428